
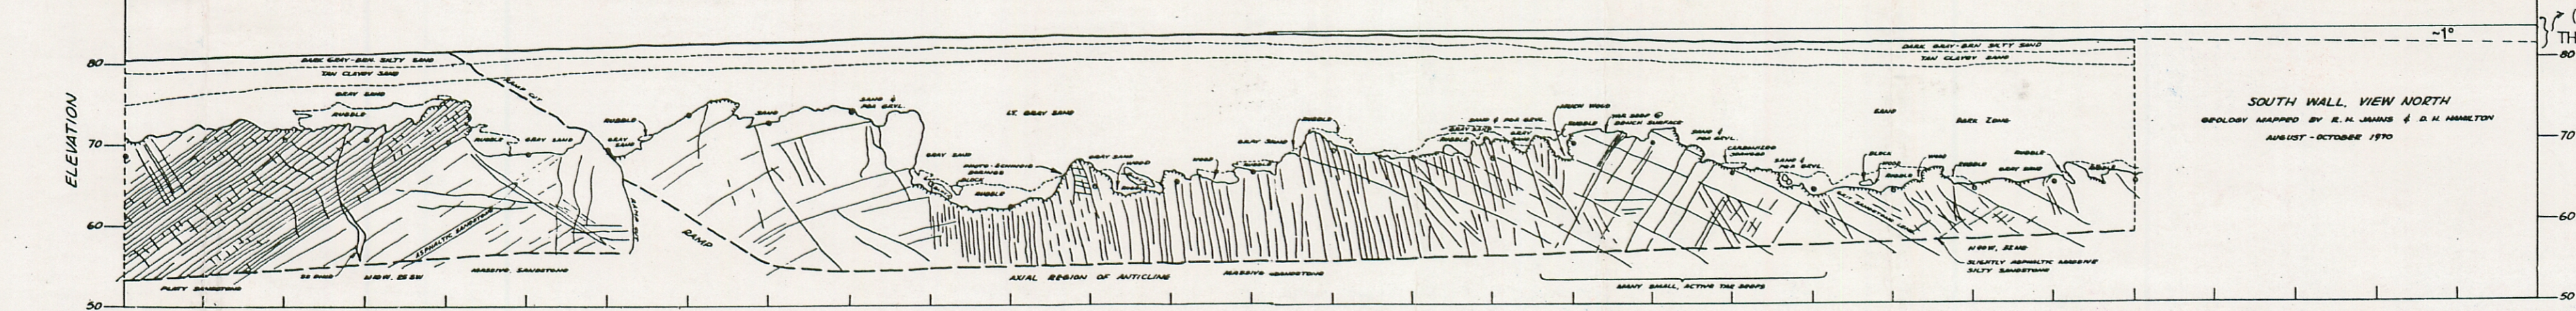


PLATE 4

Prashica 1989

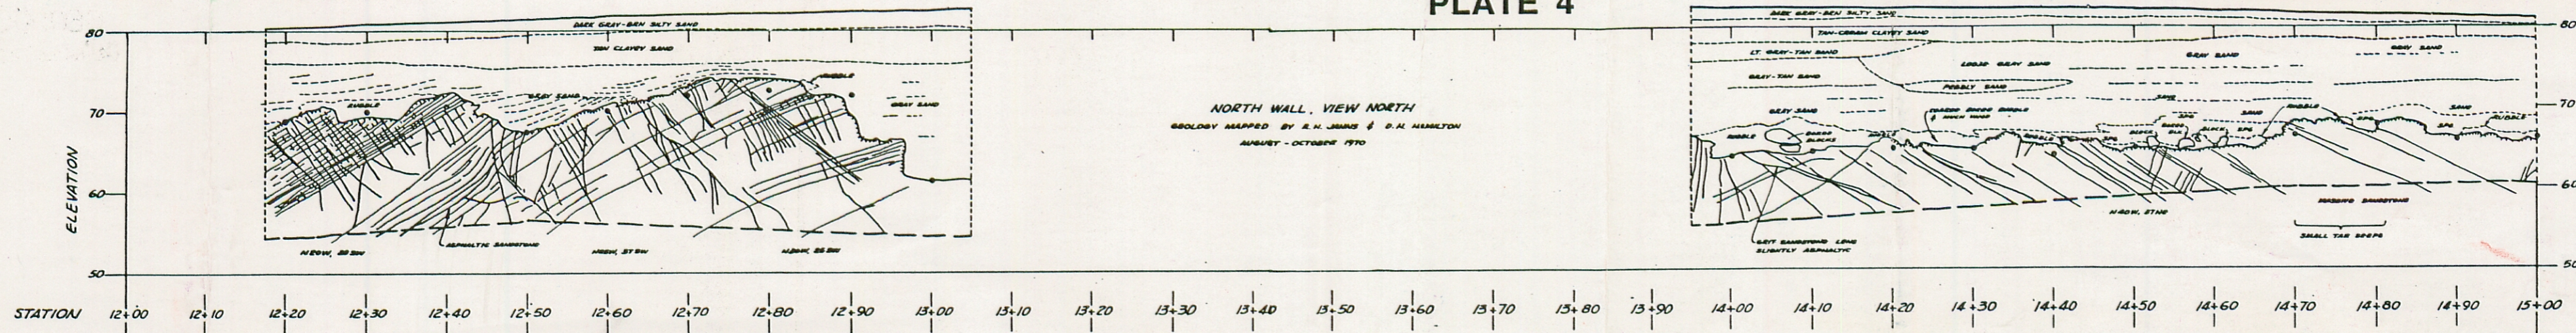

PG & E MENDOCINO POWER PLANT SITE  
TRENCH E-F, STATION 12+00-15+00  
DRAWING NO. A-14